

4MW ARDAKAN Solar Power Plant

PLOT PLAN


FRNDS-RDK-BD-001

LEGEND	
1	Concrete Wall
2	Patrol Road
3	Internal Road
4	Table With 2 String
5	Inverter 125 KVA
6	2000KVA Post

NOTES

4.0 MW PV Plant
PV Module Capacity: 720 W
Number of PV Module: 5580
Number of Solar Inverter: 31
Number of PV Module in each String: 18

4MW Solar Power Plant Project	
Client:	CONSULTANT:
CONTRACTOR:	SUB-CONTRACTOR:
TITLE : PLOT PLAN	
SCALE: 1:100	SIZE: A2
CLIENT DWG NO:	FRNDS-RDK-BD-001
REV: 00	

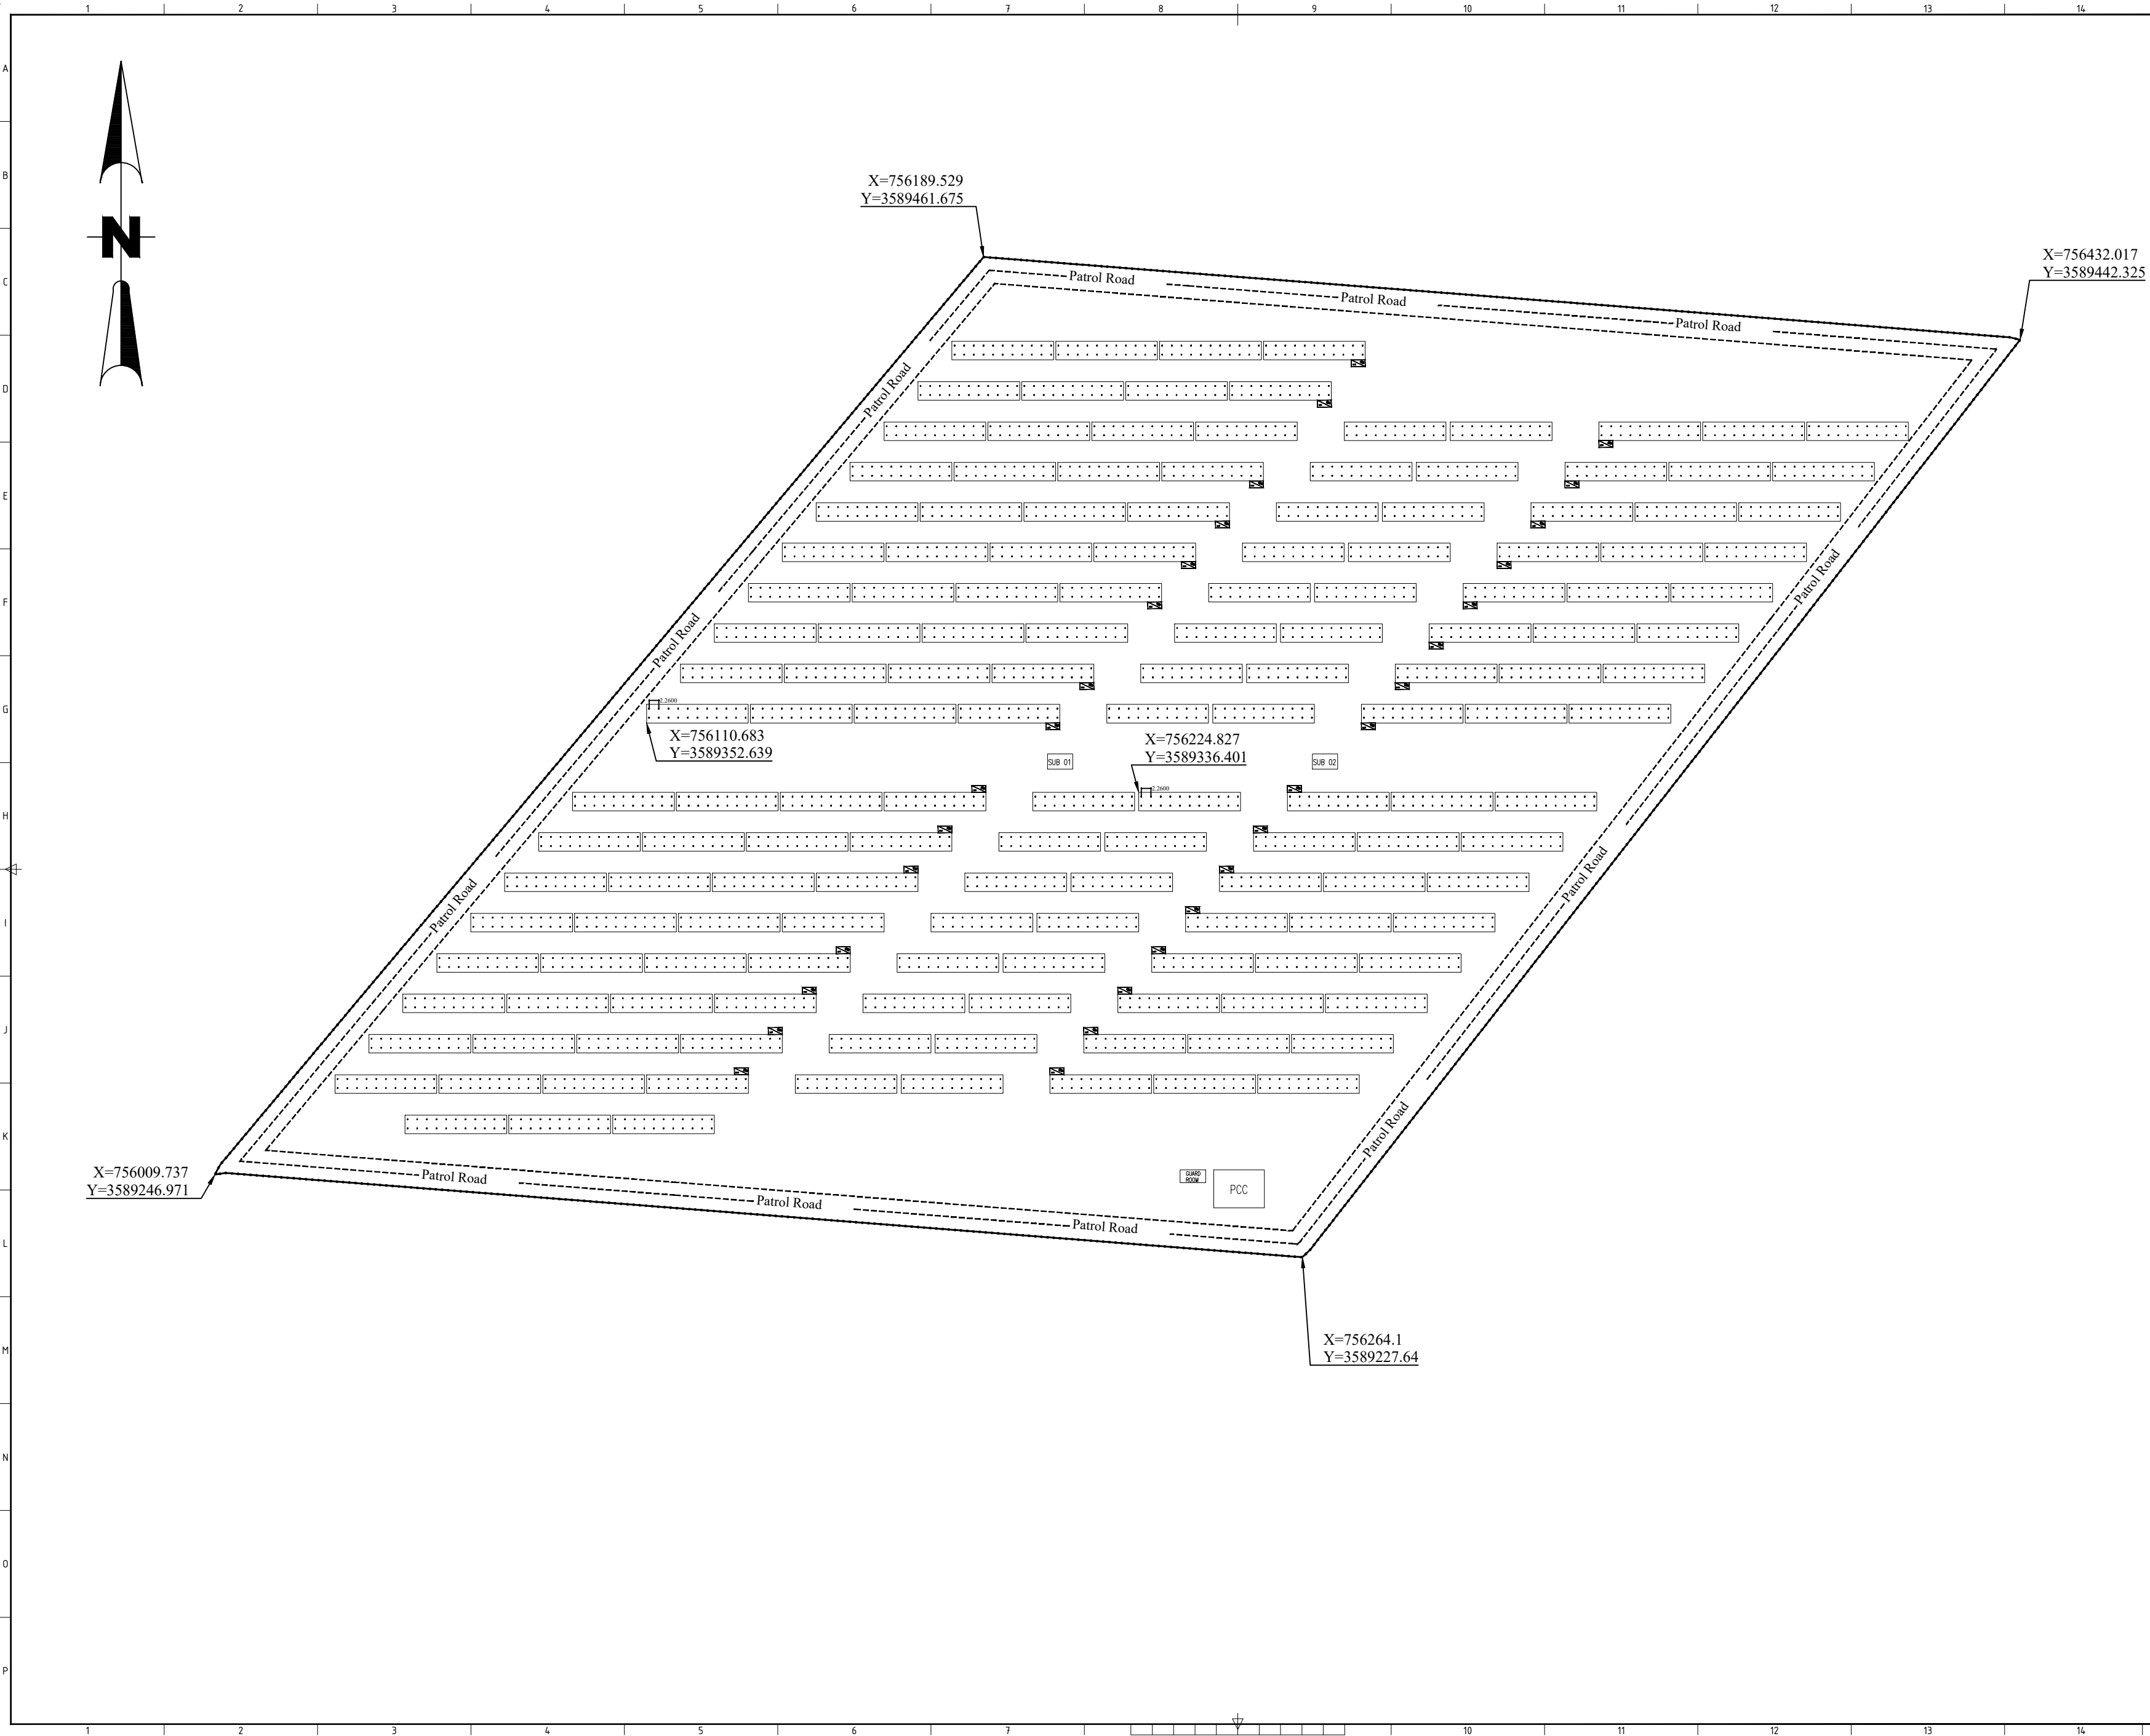

LEGEND			
1		Concrete Wall	
2		Patrol Road	
3		Internal Road	
4		Table With 2 String	
5		Inverter 125 KVA	
6		2000KVA Post	

NOTES

4.0 MW PV Plant
PV Module Capacity: 720 W
Number of PV Module: 5580
Number of Solar Inverter: 31
Number of PV Module in each String: 18

00	ISSUE FOR APPROVAL	SUBMITTANCE PREPARED	F.N.O.	CHECKED	F.N.O.	REV.	DATE
REV	DESCRIPTION						
PROJECT :							
4MW Solar Power Plant Project							
Client:				CONSULTANT:			
							
CONTRACTOR:				SUB-CONTRACTOR:			
TITLE : PLOT PLAN							
SCALE:	1:100	SIZE: A2	SHEET 2 OF 2		CONTRACT NO. :		
CLIENT DWG NO:	FRNDS-RDK-BD-001					REV:	00
15				16			