


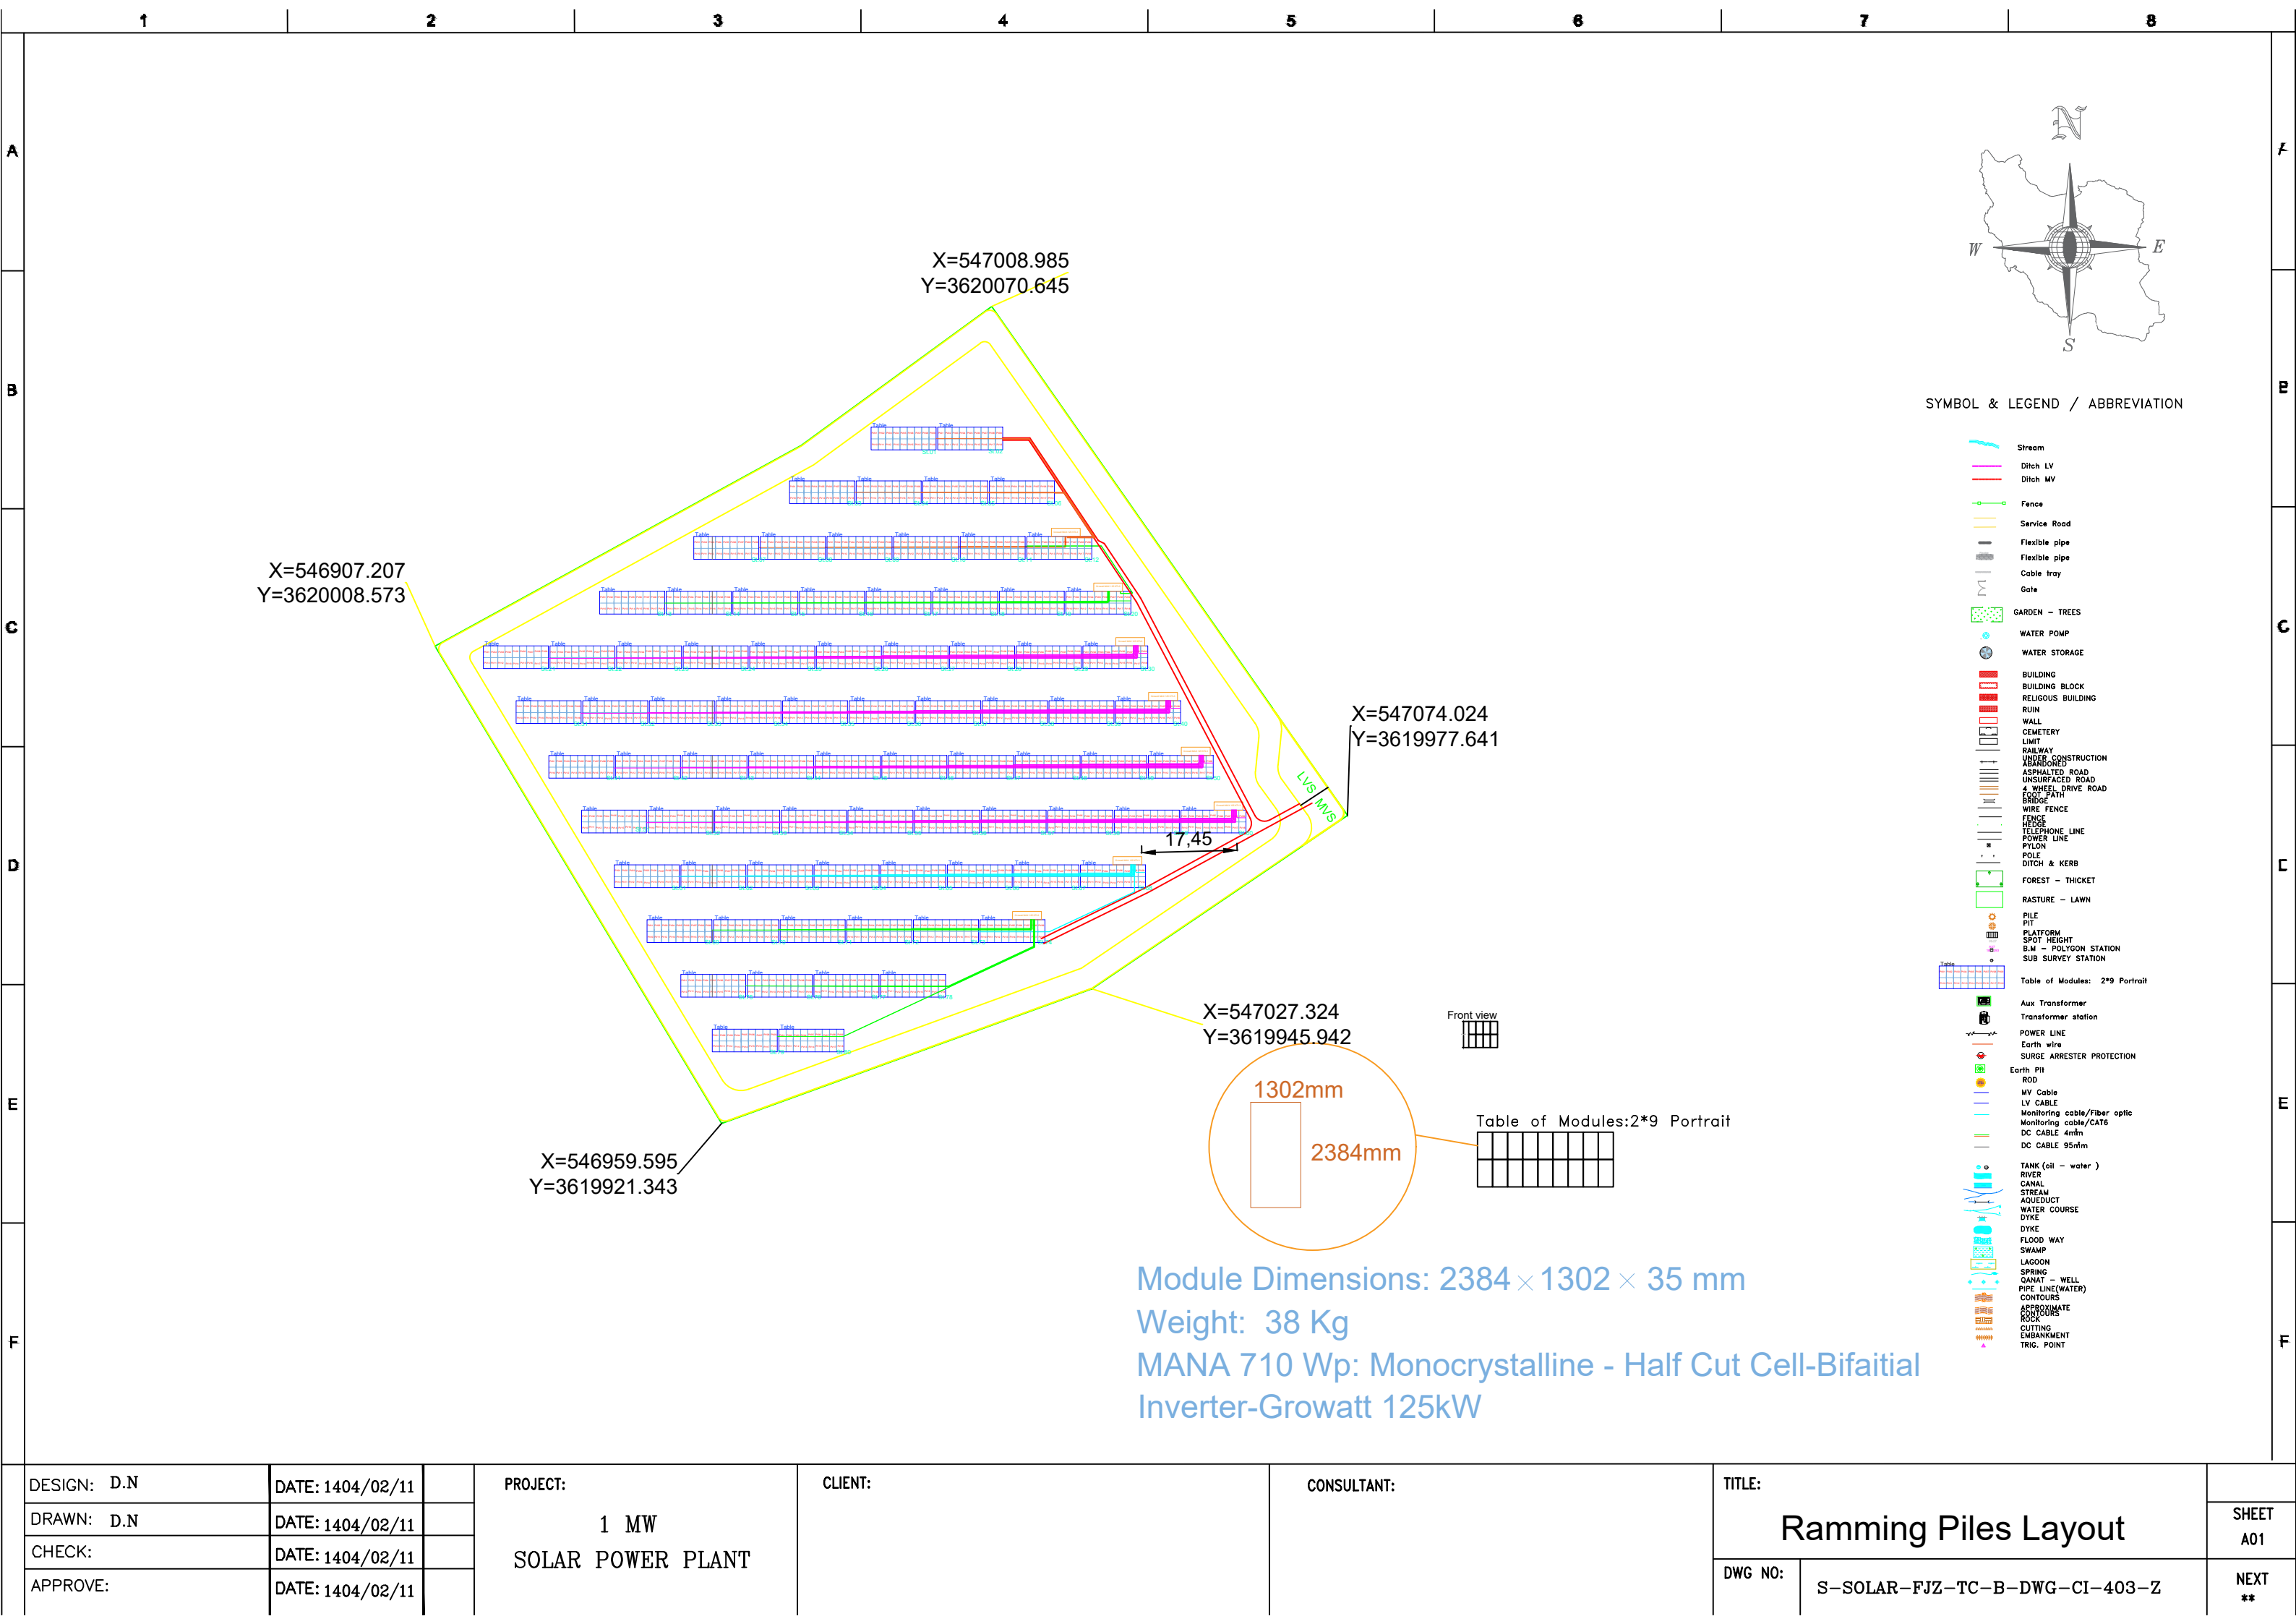

DESIGN: D.N	DATE: 1404/02/11	
DRAWN: D.N	DATE: 1404/02/11	
CHECK:	DATE: 1404/02/11	
APPROVE:	DATE: 1404/02/11	

PROJECT:
1 MW
SOLAR POWER PLANT

CLIENT:

CONSULTANT:

TITLE:	
Ramming Piles Layout	
DWG NO:	S-SOLAR-FJZ-TC-B-DWG-CI-403-Z

SHEET A01
NEXT **